


TEMPORARY 32AMP 3-PHASE BREAKER FITTED TO DISTRIBUTION BOARD SC/NE/ABGMKP PANTRY KITCHEN. TO WHICH A TEMPORARY SUPPLY MAY BE TAKEN TO EITHER SUITES 21, 22 OR 23. NO FURTHER AVAILABLE POWER TO SUITES 19 & 20.

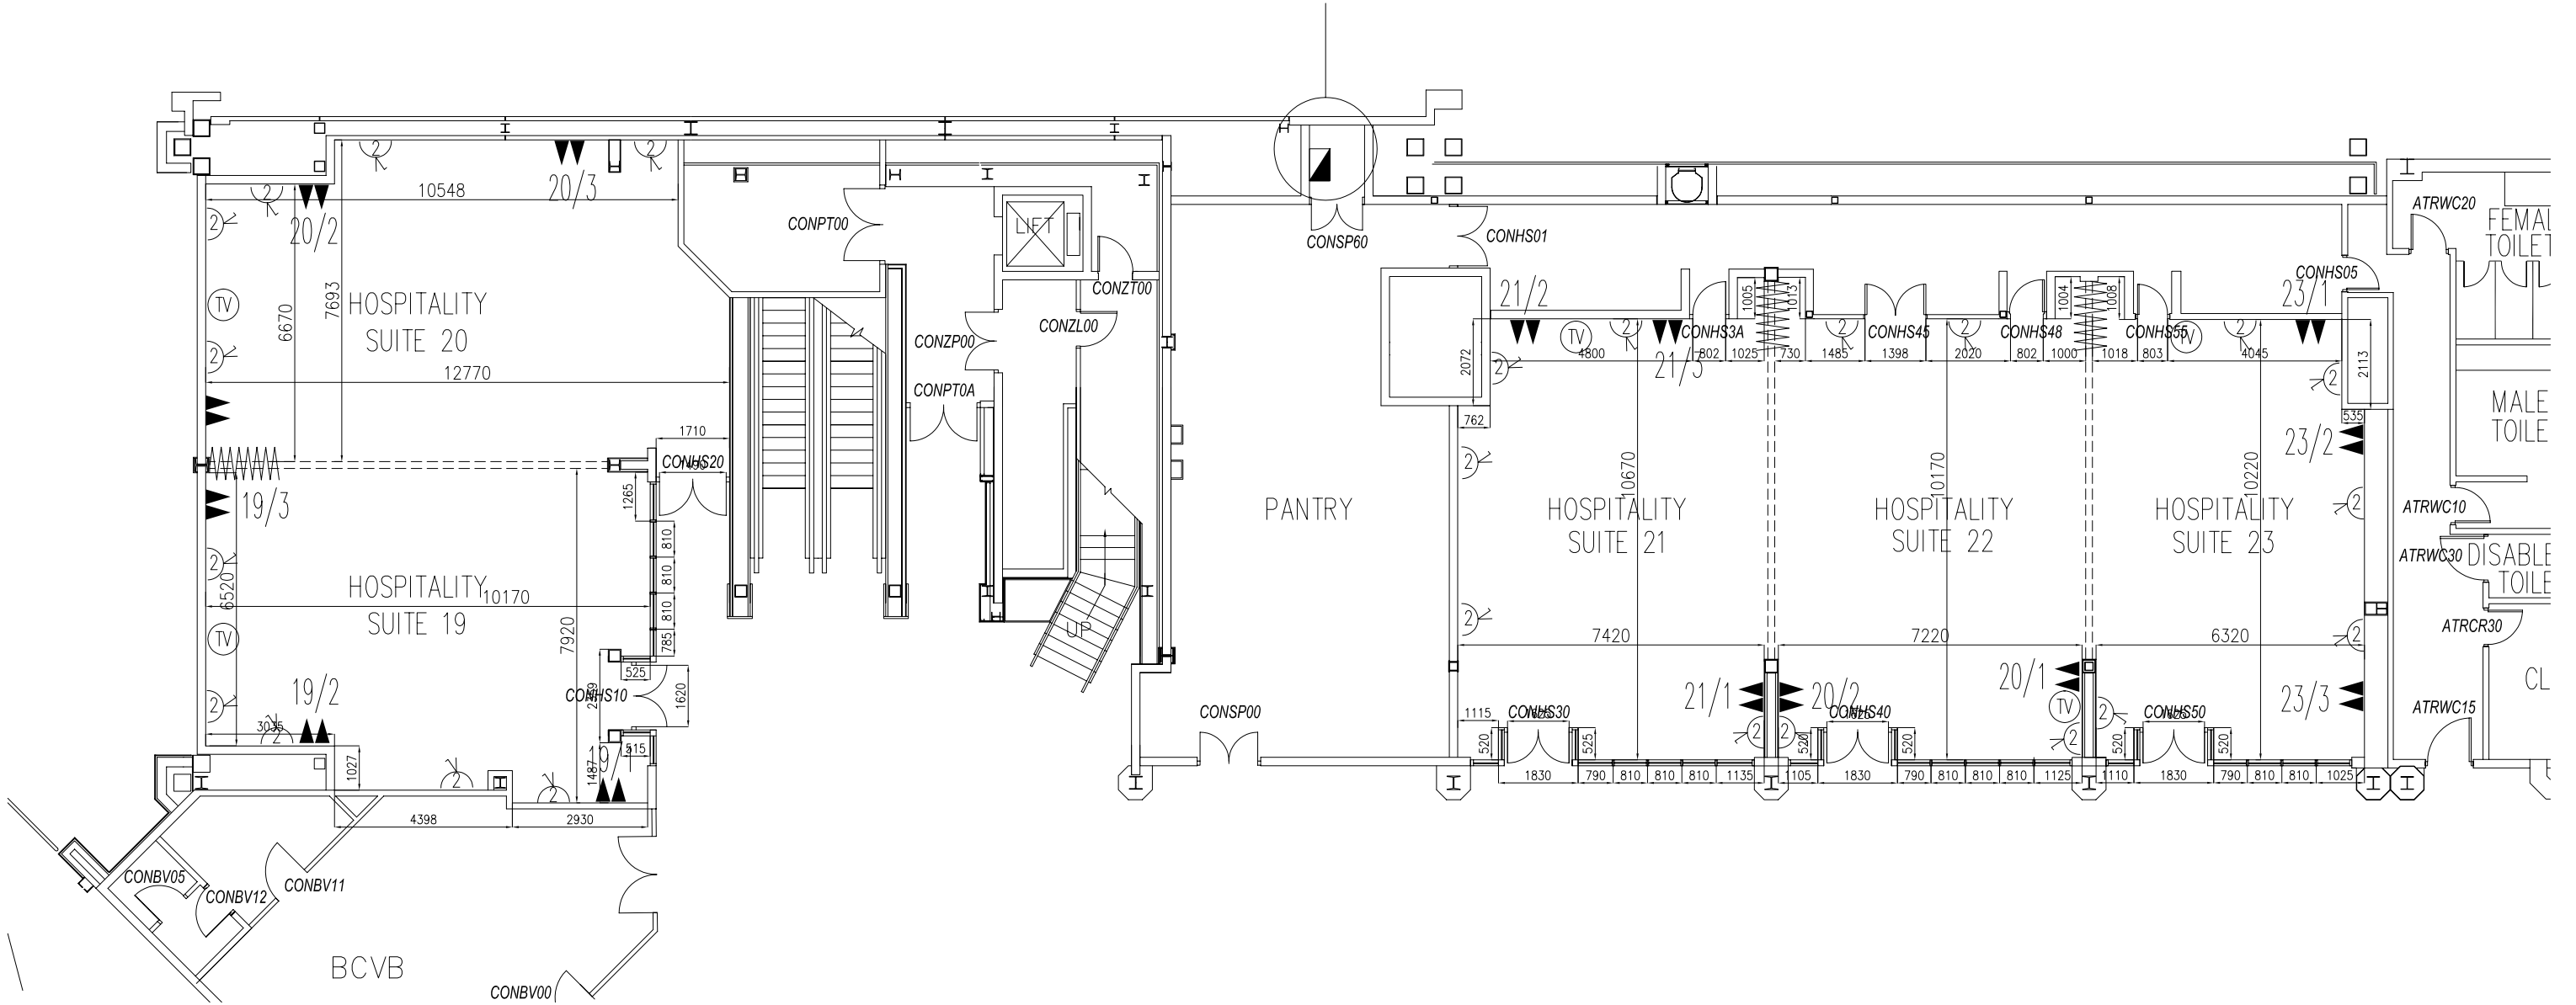

SUITES 19  
30AMPS ACROSS ALL SOCKETS. NO RCD PROTECTION

SUITES 20  
30AMPS ACROSS ALL SOCKETS. NO RCD PROTECTION

SUITES 21  
30AMPS ACROSS ALL SOCKETS. NO RCD PROTECTION

SUITES 22  
30AMPS ACROSS ALL SOCKETS. NO RCD PROTECTION

SUITES 23  
30AMPS ACROSS ALL SOCKETS. NO RCD PROTECTION

KEY

- SUITES 19-23 CEILING HEIGHT = 2.5M
- FOLDING SCREEN
- ▲ TELEPHONE JACK POINT
- ⌘ SWITCHED TWIN SOCKET OUTLET
- MANUAL FIRE ALARM
- Ⓣ TV POINT

Revisions			
No	Description	Init	Date
A.1	Further electrical details added	MRH	15/04/04
A.2	Scale was NTS	MH	17/01/05

All Changes To This Drawing Are To Be Made Using AutoCAD  
  
DO NOT SCALE

**the nec group**  
**birmingham**

COPYRIGHT  
THIS DRAWING IS THE PROPERTY OF THE NATIONAL EXHIBITION CENTRE. USE AND MAY NOT BE COPIED OR DISCLOSED FOR ANY PURPOSE WITHOUT THE WRITTEN CONSENT OF THE NATIONAL EXHIBITION CENTRE. LTD

Title CONCOURSE SUITES 19 TO 23 SERVICES SALES		
Drawn By: FC	Date: 26/05/2004	Scale: 1:75
Drawing No 2ER-3100-013	Rev No A.2	