


NO FURTHER POWER AVAILABLE TO THESE SUITES APART FROM UNDERCROFT FEO???. HOWEVER A SMALL AMOUNT OF EXTRA POWER IS AVAILABLE FROM DISTRIBUTION BOARD AT END OF CORRIDOR ADJACENT TO SUITE 14.

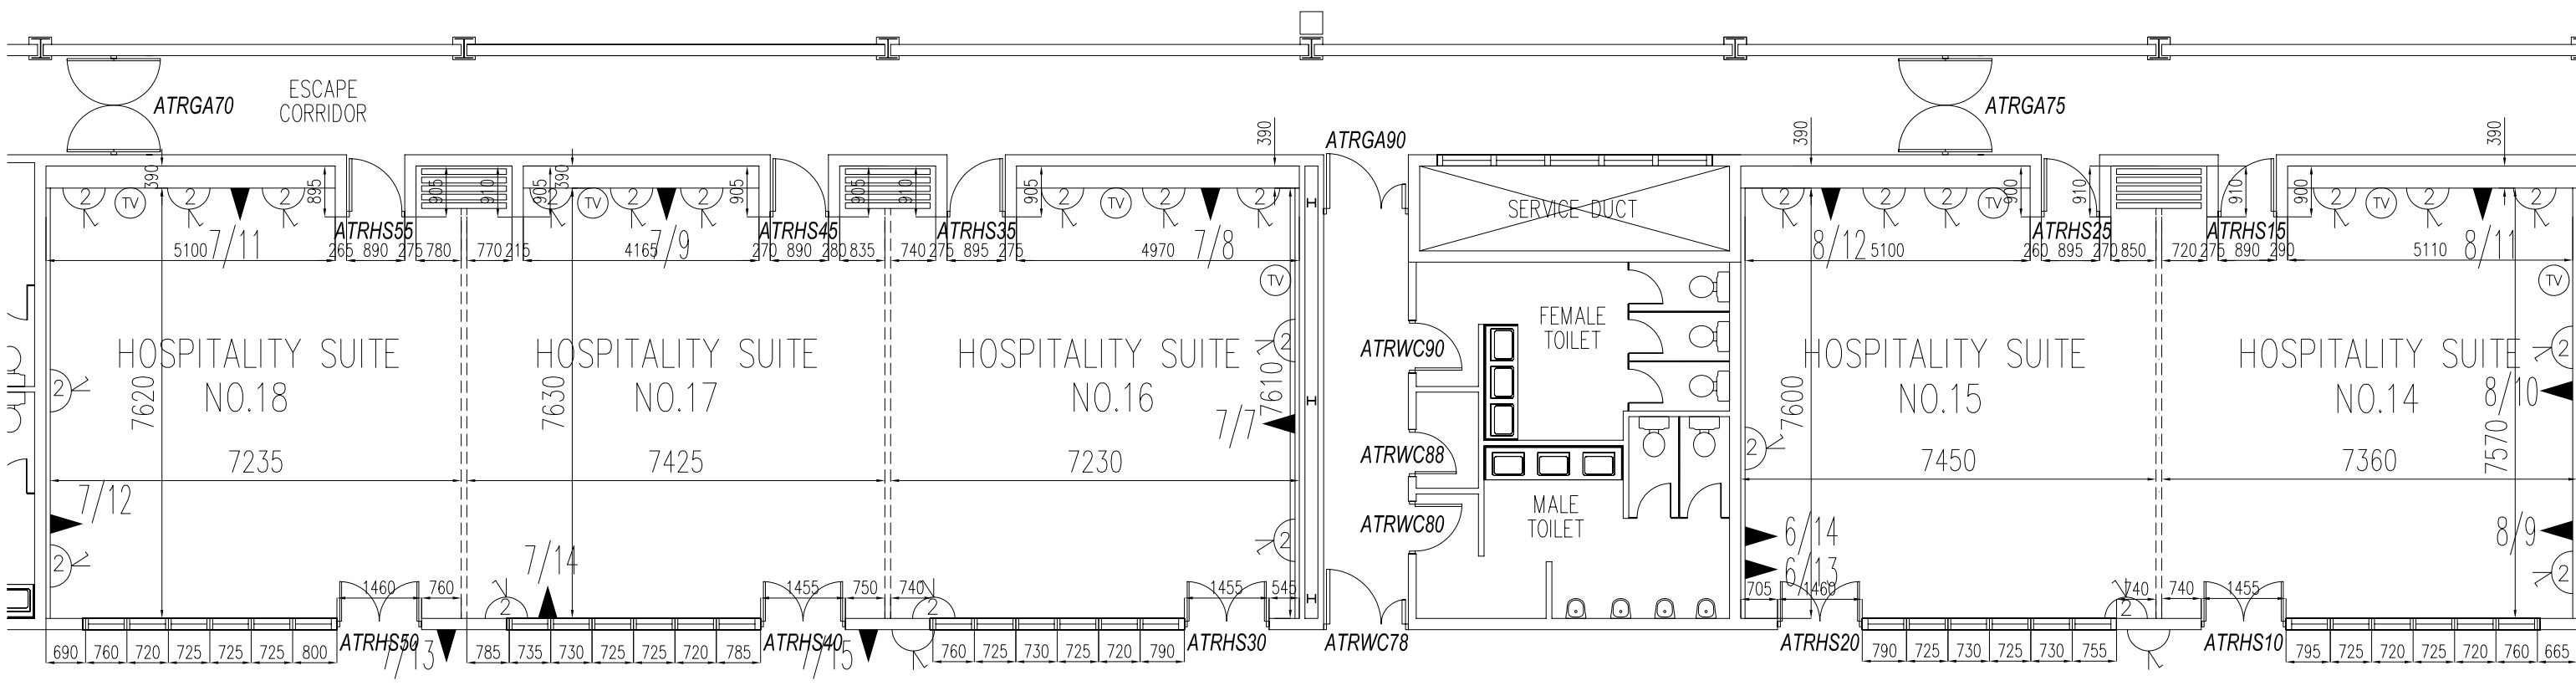

KEY

- SUITES 14-18 CEILING HEIGHT = 2.5M
- FOLDING SCREEN
- ▲ TELEPHONE JACK POINT
- ⌚ SWITCHED TWIN SOCKET OUTLET
- ⌚ SWITCHED SINGLE SOCKET OUTLET
- TV TV POINT
- ⊙ MANUAL FIRE ALARM

SUITE 14
TOTAL OF 30AMPS ACROSS ALL SOCKETS
NO RCD PROTECTION

SUITE 17
TOTAL OF 30AMPS ACROSS ALL SOCKETS
NO RCD PROTECTION

SUITE 15
TOTAL OF 30AMPS ACROSS ALL SOCKETS
NO RCD PROTECTION

SUITE 18
TOTAL OF 30AMPS ACROSS ALL SOCKETS
NO RCD PROTECTION

SUITE 26
TOTAL OF 30AMPS ACROSS ALL SOCKETS
NO RCD PROTECTION

Revisions			
No	Description	Init	Date
A.1	Electrical details added	MRH	04/05/04

All Changes To This Drawing Are To Be Made Using AutoCAD

DO NOT SCALE



COPYRIGHT THIS DRAWING IS THE PROPERTY OF THE NATIONAL EXHIBITION CENTRE. USE AND MAY NOT BE COPIED OR DISCLOSED FOR ANY PURPOSE WITHOUT THE WRITTEN CONSENT OF THE NATIONAL EXHIBITION CENTRE. LTD

Title GALLERY SUITES 14 TO 18 SERVICES SALES			
Drawn By: JW	Date: 26/05/2004	Scale: NTS	Rev No
Drawing No 2ER-3300-010			A.1